
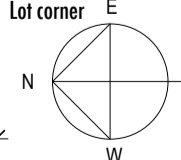


- Note All downpipes to be connected to Rainwater Tanks
- HWS Gas Boosted Solar Hot Water Service
- HR1 Handrail Type 1 - Stainless Steel wire system to comply with BCA
- Timber framed internal partition with 10mm plasterboard lining
- EM Electrical Meter Box (on wall @ eye level)
- GM Gas Meter
- SWM Sydney Water Meter

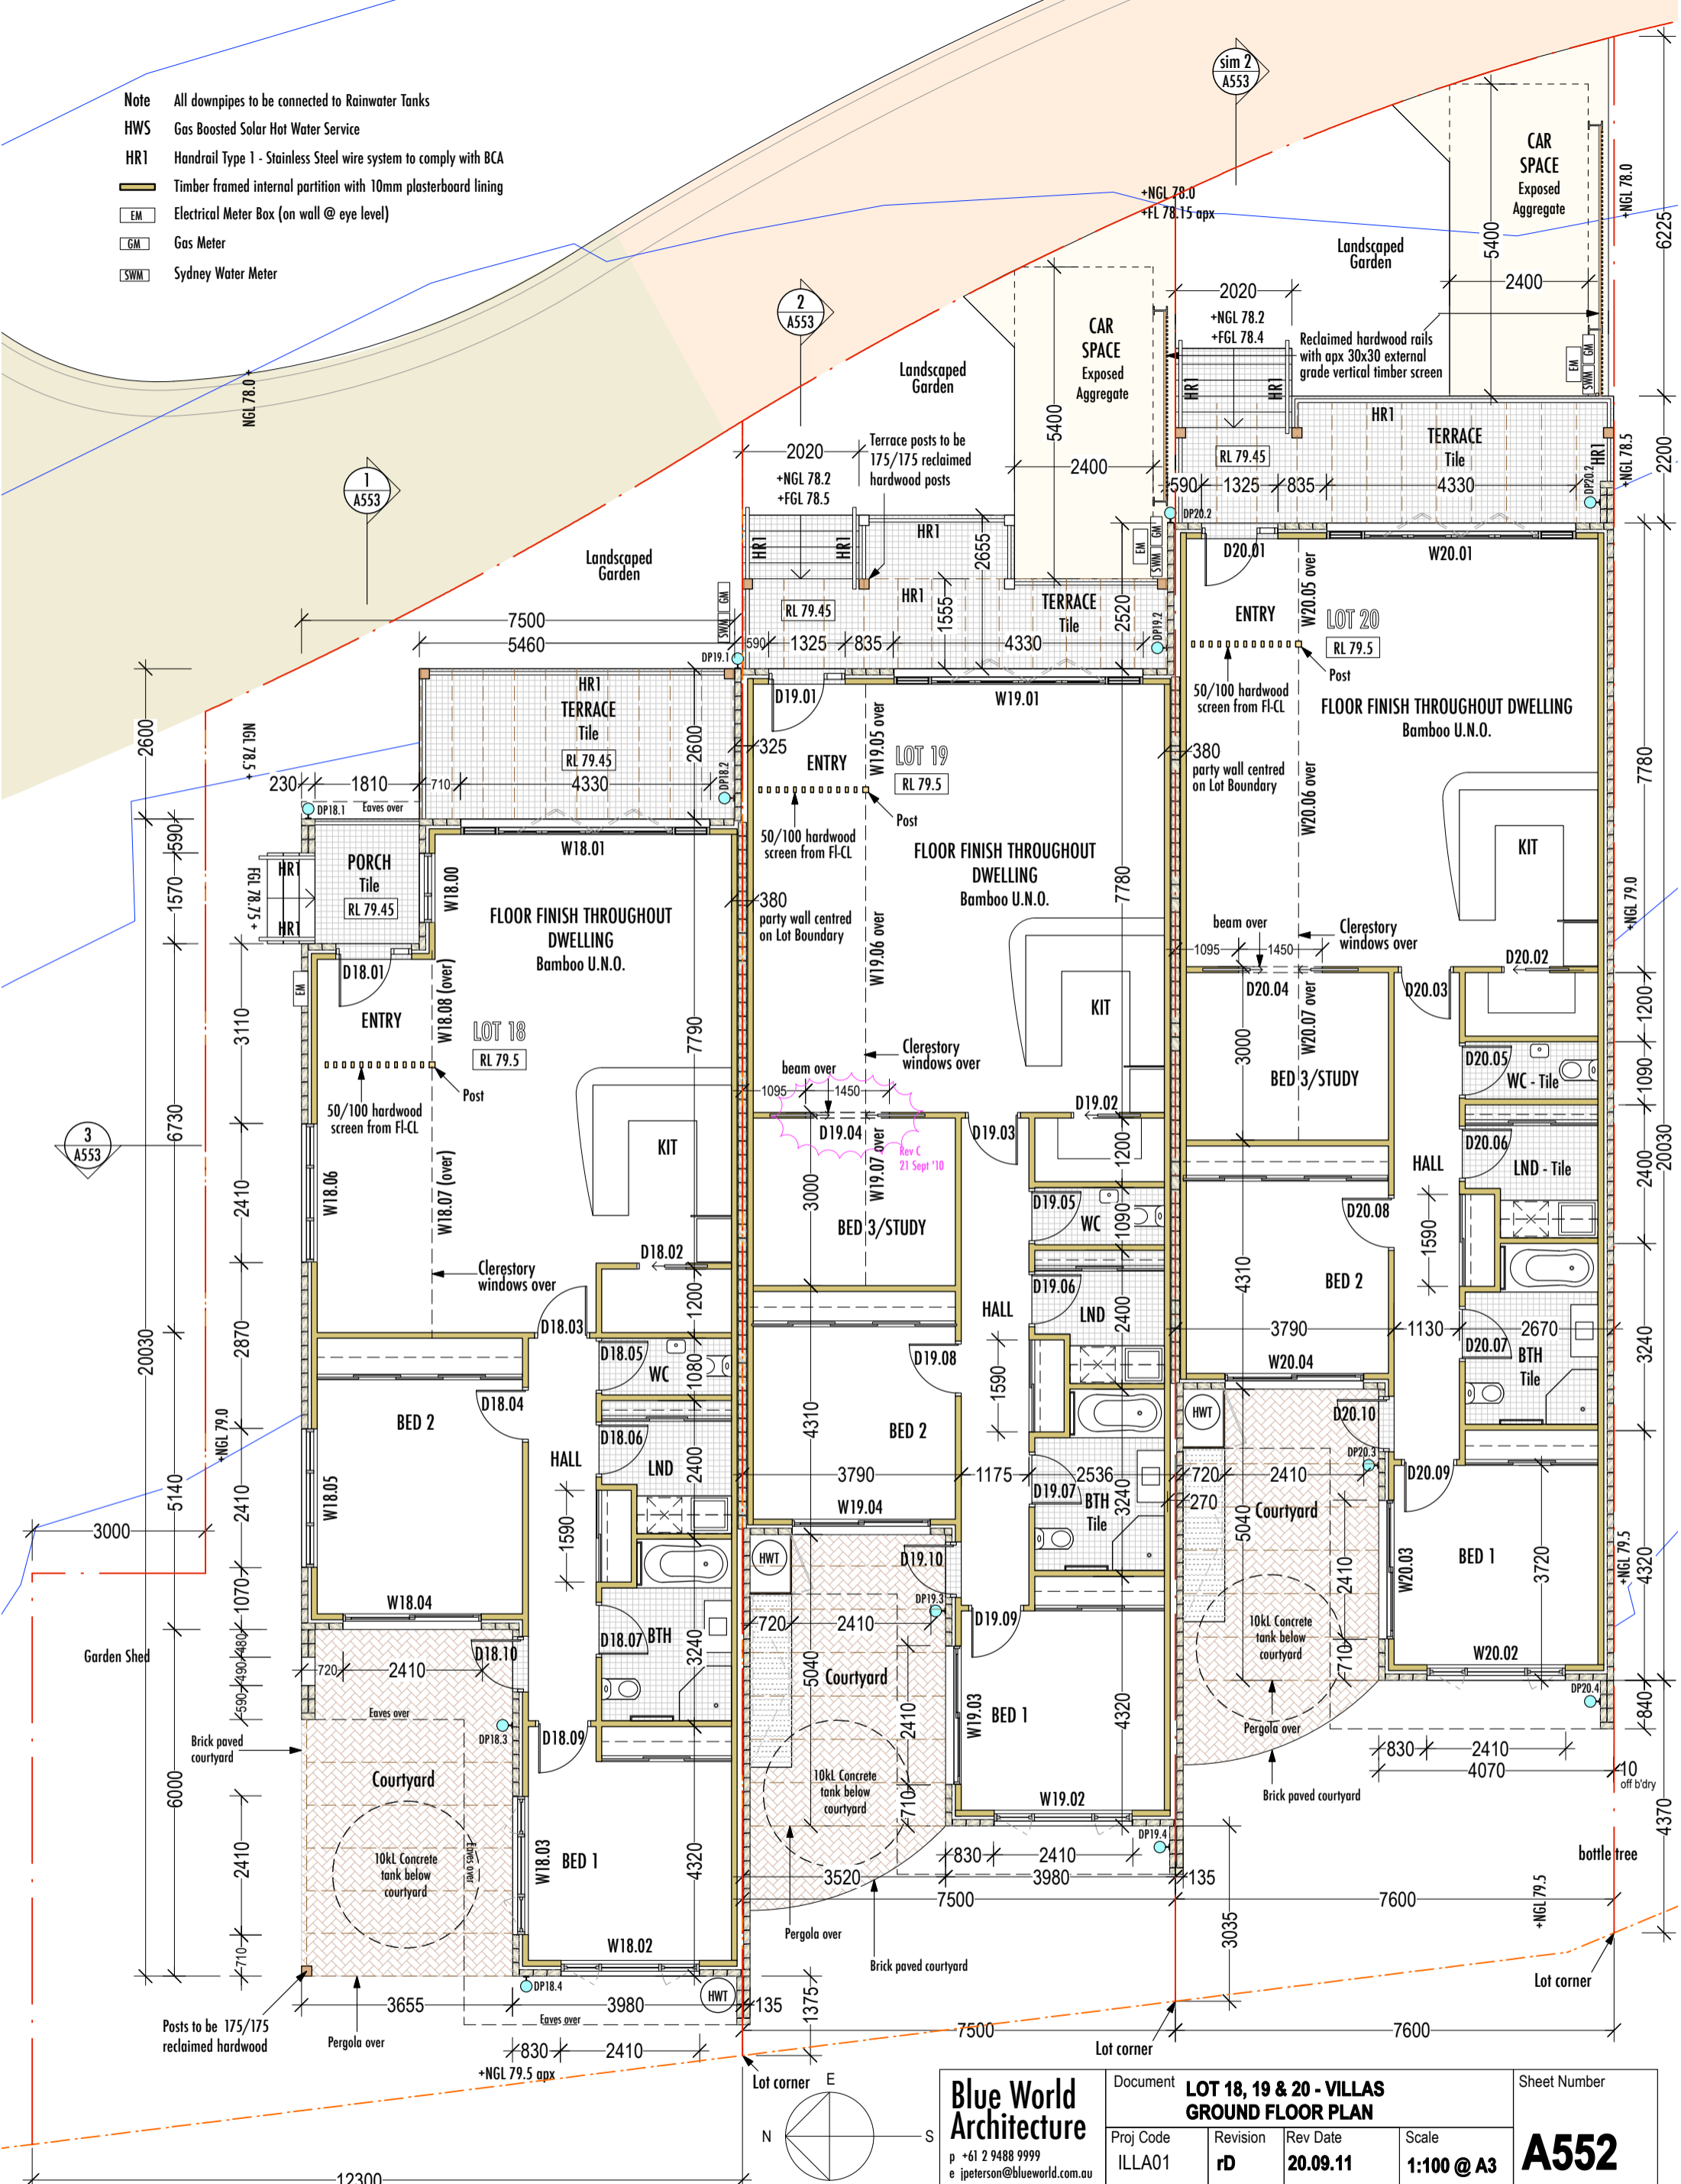

CONTRACT DOCUMENTS FOR CONSTRUCTION

Blue World Architecture p +61 2 9488 9999 e ipeterson@blueworld.com.au ABN 84 462 749 249 Copyright ©	Document LOT 18, 19 & 20 - VILLAS GROUND FLOOR PLAN	Sheet Number A552
	Proj Code ILLA01	Revision rD
Scale 1:100 @ A3		